



Republic of the Philippines  
**DEPARTMENT OF AGRICULTURE**  
 Regional Field Office 13  
 Capitol Site, Butuan City 8600  
 Tel. No: (085) 305-0092

### REQUEST FOR QUOTATION

Date: \_\_\_\_\_  
 Quotation #: \_\_\_\_\_

\_\_\_\_\_  
 Name of Company

\_\_\_\_\_  
 Address

\_\_\_\_\_  
 TIN

Please quote your lowest price inclusive of taxes in the items/s listed, subject to the General Conditions below, stating the shortest time of delivery. Submit your quotation duly signed by your representative not later than 3 days upon receipt in sealed envelope marked with the reference no. (PR# 23-07-AFD143).

**JOHNNY M. CONCON**  
 Chairperson, Bids and Awards Committee

ITEM NO.	ITEM & DESCRIPTION	BRAND	UNIT	QUANTITY	UNIT COST	TOTAL COST
	<b>Labor and Materials for the Repair of Water System and Gutter at OSAC Building</b>		lot	1		
	(See attached Program of Works)					

ABC: 190,000.00  
 Source of fund: \_\_\_\_\_

**General Conditions:**

1. All entries must be typewritten/printed in ink.
2. Delivery period within \_\_\_\_\_ calendar days based on the contract.
3. Warranty shall be for a period of six (6) months for supplies & materials, one (1) year for equipment from date of acceptance by procuring entity.
4. Price validity shall be for a period of \_\_\_\_\_ calendar days
5. PhilGEPS Registration Certificate, Business Permit, DTI Certificate and Tax Registration Certificate shall be attached upon submission of the quotation, if applicable.
6. Bidders shall submit original brochures showing specification of the products being offered.
7. Winning bidder(s) from outside Butuan City must appear personally or sent authorized representative to signed contract and claimed payments.

\_\_\_\_\_  
 Name and Signature of Canvasser

\_\_\_\_\_  
 Printed Name/Signature of Company

\_\_\_\_\_  
 Tel. No./CP No./Email Address

\_\_\_\_\_  
 Date

REPAIR OF WATER SYSTEM AND GUTTER  
AT OSAC BUILDING

DA RFO 13, CAPITOL SITE, BUTUAN CITY



Republic of the Philippines  
DEPARTMENT OF AGRICULTURE  
Caraga Region  
Capitol Site, Butuan City

# TABLE OF CONTENTS

SHEET No.	<u>SHEET CONTENTS</u>
1	----- TABLE OF CONTENTS SCHEDULE OF QUANTITIES
2	----- GROUND FLOOR WATERLINE SECOND FLOOR WATERLINE
3	----- THIRD FLOOR WATERLINE ROOF PLAN
4	----- PROJECT SIGNBOARD DETAIL


SCHEDULE OF QUANTITIES			
ITEM NO.	DESCRIPTION	UNITS	QTY.
B.5	PROJECT SIGNBOARD	1.00	EACH
901 (1)	LEAN CONCRETE	0.25	m <sup>3</sup>
903 (1)	FORMWORKS & SCAFFOLDINGS (INCLUDE SAFETY NET)	1.00	LS
1002 (3)	PVC PIPES (BLUE) WITH FITTINGS	1.00	LOT
1002 (21)	FAUCET (HIGH QUALITY)	12.00	PC
1013 (2) b1	FABRICATED METAL ROOFING ACCESSORIES (GGE. 24)	12.00	LIN.M.
1201	GATE VALVE 1/2in. DIA.	3.00	PC

Republic of the Philippines DEPARTMENT OF AGRICULTURE Caraga Region	PROJECT TITLE	REPAIR OF WATER SYSTEM & GUTTER AT OSAC BUILDING	LOCATION: DA RFO 13, BUTUAN CITY
	PREPARED BY	 GLENN D. ODOJWAN ENGINEER II	
CHECKED & REVIEWED BY	 THERESA LYN B. LIMAS ENGINEER III	SUBMITTED BY	 RENE G. MORALES CHIEF -- RAED
RECOMMENDING APPROVAL	 REBECCA R. ATEGA RTD for OPERATIONS	APPROVED BY	 ENGR. RICARDO M. ONATE, JR. REGIONAL EXECUTIVE DIRECTOR
SHEET No.	1		
SHEET No.	4		

LEGEND	
	1/5in. PVC PIPE (BLUE) COLD WATER LINE
GV	1/2in. GATE VALVE

NOTE:

- REPLACE FAUCET AT LAVATORY & TOILET

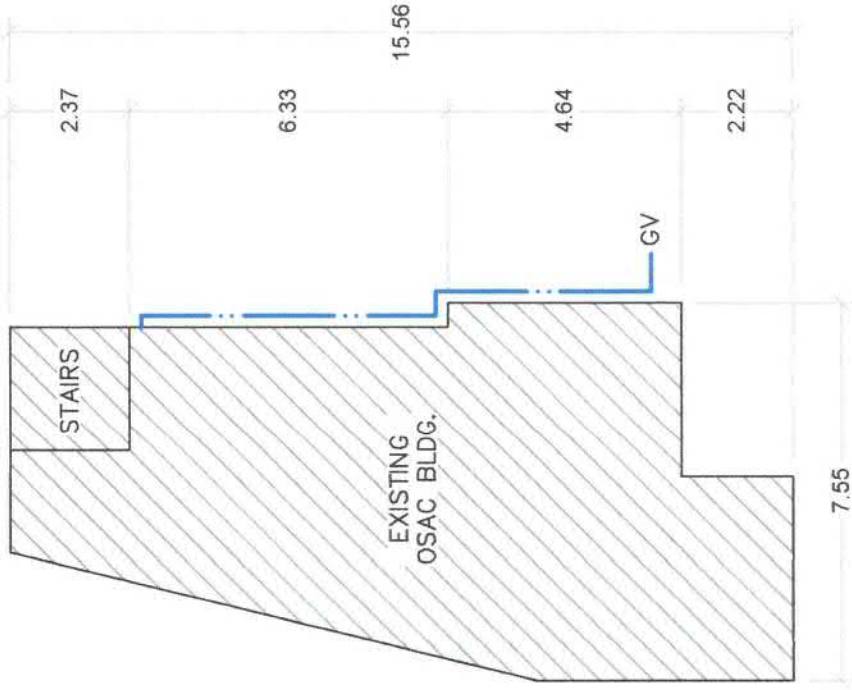

A  
1

GROUND FLOOR WATERLINE

SCALE: 1:150m



B  
1

SECOND FLOOR WATERLINE


SCALE: 1:150m

Republic of the Philippines DEPARTMENT OF AGRICULTURE Caraga Region	PROJECT TITLE REPAIR OF WATER SYSTEM & GUTTER AT OSAC BUILDING LOCATION: DA RFO 13, BUTUAN CITY	PREPARED BY  GLENN D. ORTOGUAN ENGINEER II	CHECKED & REVIEWED BY  THERESA LYN B. LIMAS ENGINEER III	SUBMITTED BY  RENE Q. MORALES CHIEF - RAED	RECOMMENDING APPROVAL  REBECCA R. ATECA RTD for OPERATIONS	APPROVED BY  ENGR. RICARDO M. ONATE, JR. REGIONAL EXECUTIVE DIRECTOR	SHEET No. 2
							4

LEGEND	
	1/5in. PVC PIPE (BLUE) COLD WATER LINE
GV	1/2in. GATE VALVE

NOTE:

- REPLACE FAUCET AT LAVATORY & TOILET

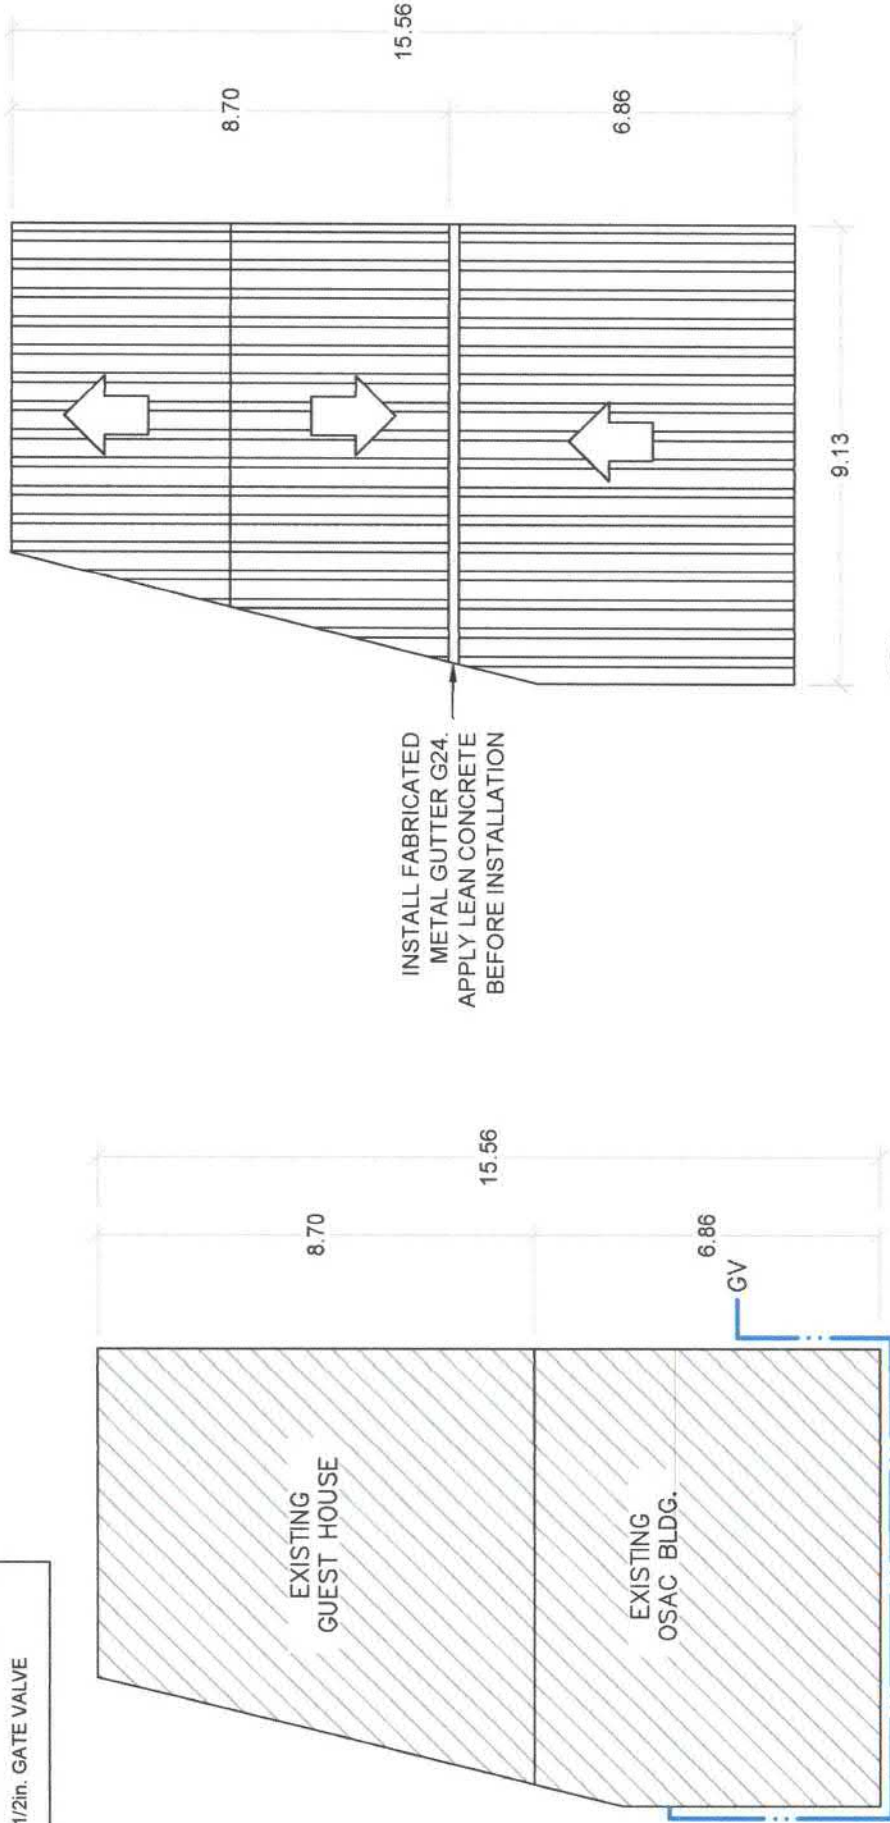


**B**  
1  
THIRD FLOOR WATERLINE  
SCALE: 1:150m

**B**  
1  
ROOF PLAN  
SCALE: 1:150m

Republic of the Philippines DEPARTMENT OF AGRICULTURE Caraga Region	PROJECT TITLE	REPAIR OF WATER SYSTEM & GUTTER AT OSAC BUILDING	LOCATION: DA RFO-13, BUTUAN CITY
	PREPARED BY	 GLENN D. ODOJAN ENGINEER II	CHECKED & REVIEWED BY  THESSA LYN B. LIMAS ENGINEER III
	SUBMITTED BY	 RENE Q. MORALES CHIEF - RAED	RECOMMENDING APPROVAL  REBECCA R. ALIGA RTD for OPERATIONS
	APPROVED BY	 ENGR. RICARDO M. ONATE, JR. REGIONAL EXECUTIVE DIRECTOR	SHEET No. 3
			4

DESIGN & FORMAT OF THE TARPAULIN

1. TARPAULIN , WHITE, 8FT x 8FT
2. RESOLUTION: 70dpi
3. FONT: HELVETICA
4. FONT SIZE; MAIN INFORMATION – 3"
5. SUB—INFORMATION – 1"
6. FONT COLOR: BLACK





Republic of the Philippines  
DEPARTMENT OF AGRICULTURE  
Caraga Region  
Capital Site, Butuan City  
Tel. No. (085) 342-4092, Telefax No. (085) 341-2114

Project Name/s  
Location  
Implementing Agency/ies/DA-Caraga Region  
Development Partners  
Contractor/Supplier  
Brief Description

Cost:  
Fund Source/s

Project Date		Project Status			
Duration	Started	Target Date of Completion	Percentage of Completion	Cost Incurred to Date	Remarks Completed
80 C.D.					
For particulars or complaints about this project, please contact Regional Office or Cluster which has audit jurisdiction on this project					

COA Regional Office No./Cluster : XIII-CARAGA  
Address SOUTH MONTILLA BOULEVARD, BUTUAN CITY  
Contact No. (085) 342-567 or text COA Citizen's Desk at (0915) 971987

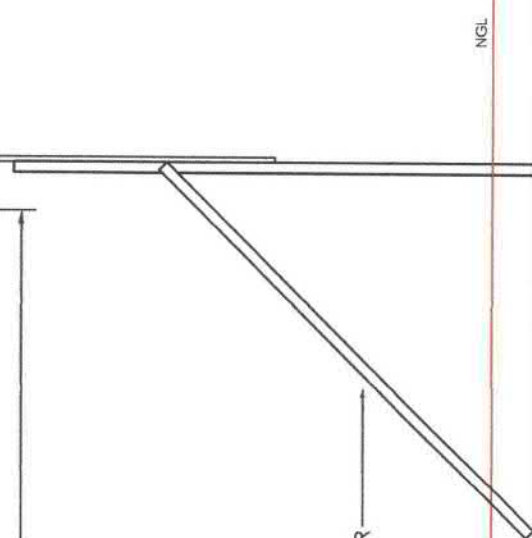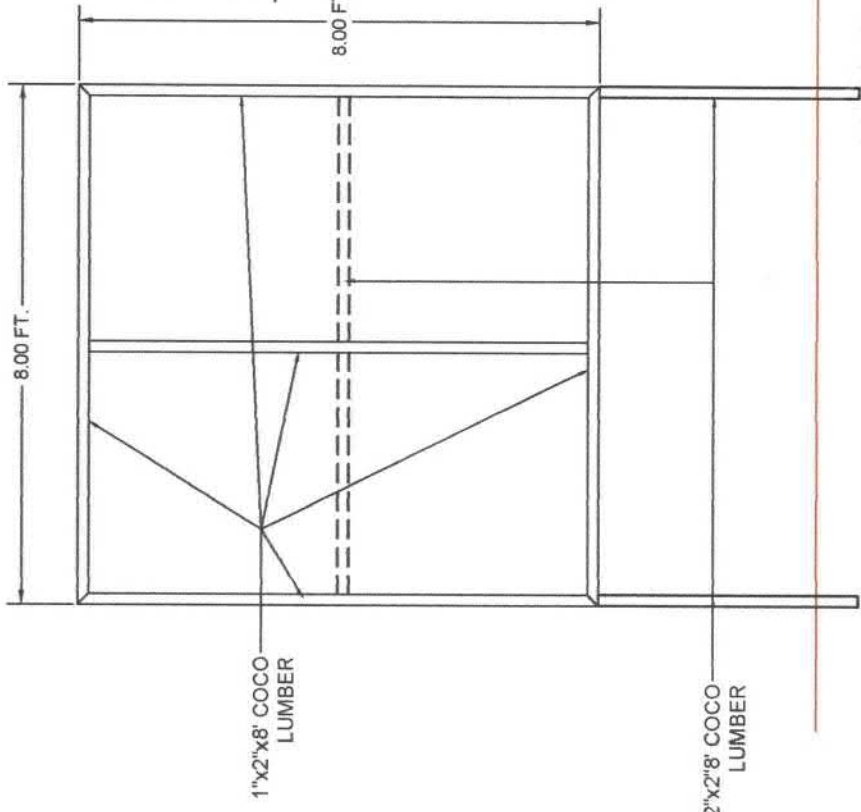

FRONT VIEW  
SCALE 1:25 MTS

RIGHT & LEFT SIDE VIEW  
SCALE 1:25 MTS

Republic of the Philippines DEPARTMENT OF AGRICULTURE Caraga Region	PROJECT TITLE	PREPARED BY	CHECKED & REVIEWED BY	SUBMITTED BY	RECOMMENDING APPROVAL	APPROVED BY	SHEET No.
	REPAIR OF WATER SYSTEM & GUTTER AT OSAC BUILDING <small>LOCATION: DA REO 13, BUTUAN CITY</small>	 GLENN D. ODIQJAN ENGINEER II	 THESSA LYN B. LIMAS ENGINEER III	 RENE Q. MORALES A CHIEF – RAED	 REBECCA R. ATEGA RTD for OPERATIONS	 ENGR. RICARDO M. ONATE, JR. REGIONAL EXECUTIVE DIRECTOR	4  4