



REQUEST FOR QUOTATION

Date: _____
 Quotation #: _____

Name of Company _____

Address _____

TIN _____

Please quote your lowest price inclusive of taxes in the items/s listed, subject to the General Conditions below, stating the shortest time of delivery. Submit your quotation duly signed by your representative not later than _____ in sealed envelope marked with the reference no. (PR # J3 06. F0219)

JOHNNY M. CONCON

Chairperson, Bids and Awards Committee

ITEM NO.	ITEM & DESCRIPTION	UNIT	QUANTITY	UNIT COST	TOTAL COST
	Labor and Materials for the Construction of Nursery for Vegetable Seedlings				
	Location:				
	1. CSU, Ampayon, Butuan City (1 unit)	unit	1		
	2. KNHS, Kinamlutan, Butuan City (1 unit)	unit	1		
	<i>Please see attached BOQ and Plans</i>				
	<i>In reference to the Practice of Professional Agricultural Engineers, pursuant to RA 10915, all plans, designs, drawings, estimates, specifications, and other documents related to agriculture both public and private, shall be signed, stamped and received by Agricultural and Biosystems Engineers.</i>				

ABC: 900,000.00

Source of fund: HVCDP 2023

General Conditions:

1. All entries must be typewritten/printed in ink.
2. Delivery period within _____ calendar days based on the contract.
3. Warranty shall be for a period of six (6) months for supplies & materials, one (1) year for equipment from date of acceptance by procuring entity.
4. Price validity shall be for a period of _____ calendar days
5. PhilGEPS Registration Certificate, Business Permit, DTI Certificate and Tax Registration Certificate shall be attached upon submission of the quotation, if applicable.
6. Bidders shall submit original brochures showing specification of the products being offered.
7. Winning bidder(s) from outside Butuan City must appear personally or sent authorized representative to signed contract and claimed payments.

After having carefully read and accepted your General Conditions, I/We quote on the item at prices noted above.

 Printed Name/Signature of Company

 Name and Signature of Convasser

 Tel. No. / CP No. / email address

 Date

Republic of the Philippines



DEPARTMENT OF AGRICULTURE








CARAGA REGION
CAPITOL SITE, BUTUAN CITY


CONSTRUCTION OF NURSERY FOR VEGETABLE SEEDLINGS

BILL OF QUANTITIES

FOR NURSERY:

ITEM NUMBER	DESCRIPTION	QUANTITY	UNIT
B.5	PROJECT BILLBOARD/SIGNBOARD	1.00	EACH
903(2)	FORMWORKS AND FALSEWORKS	1.00	LUMP SUM
2300	REINFORCING STEEL BAR	185.56	KILOGRAMS
1700(1)	CONCRETE STRUCTURE (CLASS 'A')	5.50	CUBIC METER
403(7)	STRUCTURAL STEEL FURNISHED FABRICATED & ERECTED	1305.70	KILOGRAMS
1013(2) P1	FABRICATED METAL ROOFING ACCESSORY - GUTTER	17.00	LINEAR METER
901	MASONRY WORKS (CLASS 'A')	10.40	SQUARE METER
804(4)	GRAVEL FILL	8.15	CUBIC METER
1032(1)c	PAINTING WORKS (STEEL)	52.00	SQUARE METER
SPL1	NET INSTALLATION	114.00	SQUARE METER
SPL2	UV SHEET INSTALLATION	56.00	SQUARE METER
1002(4)	PLUMBING FIXTURES	1.00	LUMP SUM

 Republic of the Philippines DEPARTMENT OF AGRICULTURE CARAGA REGION Capital Drive, Butuan City	
Project Title: CONSTRUCTION OF NURSERY FOR VEGETABLE SEEDLINGS	Prepared by:  DAN LOWELL S. PALMEJAR HYDOP TECHNICAL STAFF
Checked and Reviewed by:  ENGR. THERESA LYN B. LIMAS ENGINEER III	Submitted by:  ENGINEER OF MATERIALS CHIEF, RABD
Noted by:  DALINGA M. MANALIS HYDOP FOCAL PERSON	Recommended by:  RECTOR RID FOR OPERATIONS
Approved:  ENGR. RICARDO M. ONATE, JR. REGIONAL EXECUTIVE DIRECTOR	Sheet No. 1

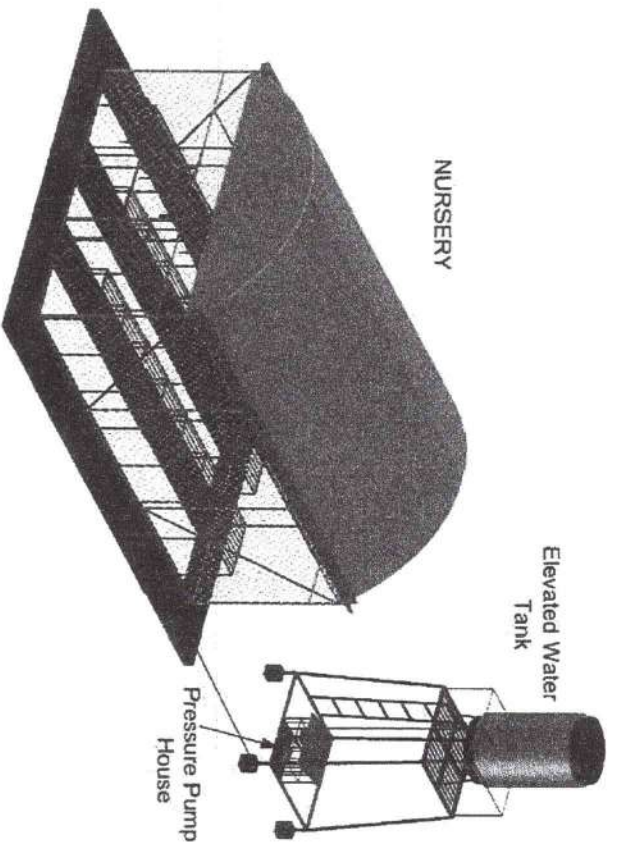

PERSPECTIVE VIEW

GENERAL NOTES AND SPECIFICATIONS:

1. The location of liquid waste facility shall conform with the existing zoning, land use standards, rules and regulations set by Department of Environment and Natural Resources (AO 34 and 35) and other national policies such as Water Code (PD 1067) and Environmental Code on Solid and Liquid Waste Disposal (PD 1152).
2. All materials to be use shall be brand new.
3. Use 8'x8' COA format tarpaulin with frame for project signage.
4. All welding works shall be fully-welded, plain finished, and painted w/ silver oxide for rust resistant.

Republic of the Philippines DEPARTMENT OF AGRICULTURE CARAGA REGION Capital Drive, Butuan City			
Project Title: CONSTRUCTION OF NURSERY FOR WASTEWATER SERVICES	Prepared by: DAN LOWELL S. PALMAR HVCDP TECHNICAL STAFF	Checked and Reviewed by: ENGR. JHESALYN B. LIMAS ENGINEER III	Submitted by: ENGR. RODERIC M. REYES CIVIL ENGINEER
Location:	Noted by: DAULINDAY MAMAS HVCDP FOCAL PERSON	Recommended by: REBECCA R. ATIENZA KID FOR OPERATIONS	Approved: ENGR. RICARDO M. ORANTE, JR. REGIONAL EXECUTIVE DIRECTOR
			Sheet No. II

NOTE:
ALL DIMENSIONS ARE IN CENTIMETERS UNLESS
OTHERWISE SPECIFIED



Republic of the Philippines
DEPARTMENT OF AGRICULTURE
Cebu Region
Cebu City, Cebu City
Tel. No. (085) 342-4092, Telex No. (085) 341-2114

Project Name: Nursery for Vegetable Seedlings
Location: [Blank]
Implementing Agency/Team: DA-Cebu Region
Development Partner: [Blank]
Contractor/Supplier: [Blank]
Bids Description: [Blank]

2.40M

Project Details		Project Status		Remarks
Project Date	Target of Completion	Percentage As of Date Incurred	Cost Completed to Date	

For particular or complaints about this project, please contact Regional Office or Cluster which has audit jurisdiction on the project

COA Regional Office No. 7/Zone 1, XHICARAGA
Address: SOUTH MONTILLA BOULEVARD, BUTUAN CITY
Contact No.: (085) 342-567 or text COA Citizens' Desk at 0915591957


FONT COLOR : BLACK
RESOLUTION : 70dpi
FONT : HELVETICA
FONT SIZE : 11"
SUB- INFORMATION : 11"

PROJECT BILLBOARD DETAILS

NOT

TO

SCALE

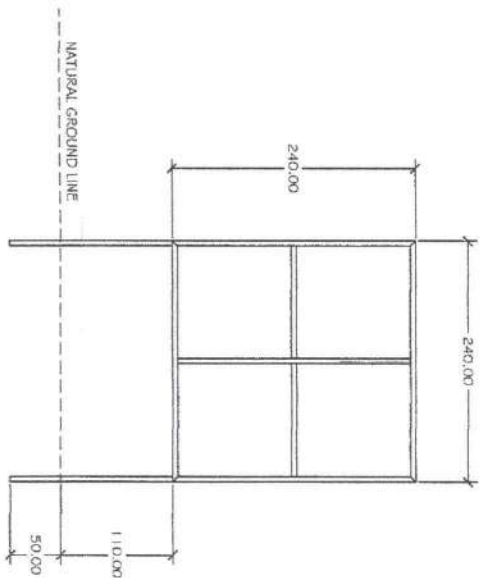


FRAMING DETAILS

SCALE

1:50

MTS

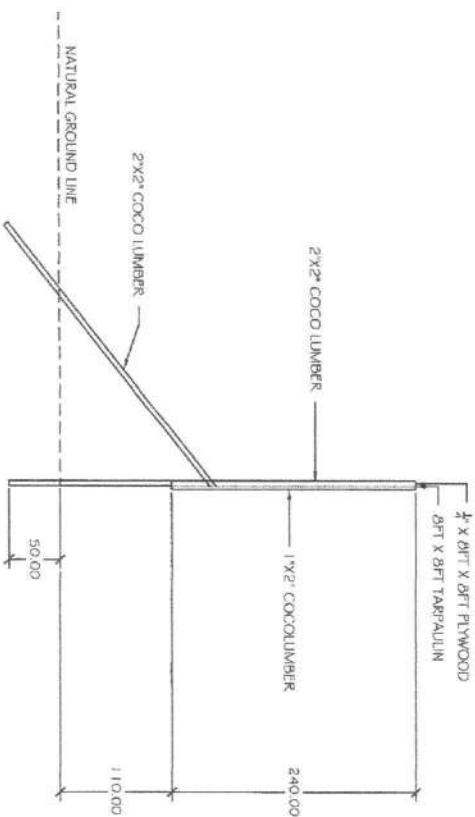

LEFT & RIGHT SIDE ELEVATION

SCALE


1:50

MTS

<p>Republic of the Philippines DEPARTMENT OF AGRICULTURE CAGAYA REGION Capital Drive, Butuan City</p>					
Project Title:	Prepared by:	Checked and Reviewed by:	Submitted by:	Noted by:	Recommended by:
CONSTRUCTION OF MISERY FOR VEGETABLE SEEDLINGS	DAN LOPEZ S. PALMARES HYCDP TECHNICAL STAFF	ENGR. TERESA LYN B. LAMAS ENGINEER III	ENGR. RAFFA Q. MORALES CHIEF/RAID	DAWINDA W. TAMAMUS HYCDP FOCAL PERSON	REBECCA ANGELA KID FOR OPERATIONS
Location:					
Approved:	<p>ENGR. KRISTO M. ORANTE, JR. REGIONAL EXECUTIVE DIRECTOR</p>				Sheet No.:
					1 9

NOTE:
ALL DIMENSIONS ARE IN CENTIMETERS UNLESS OTHERWISE SPECIFIED

NOTE:
ALL G.I. PIPES ARE FULLY-WELD AND THE UV SHEETS AND INSECT NETS ARE LOOK ON THE LOCKING PROFILES

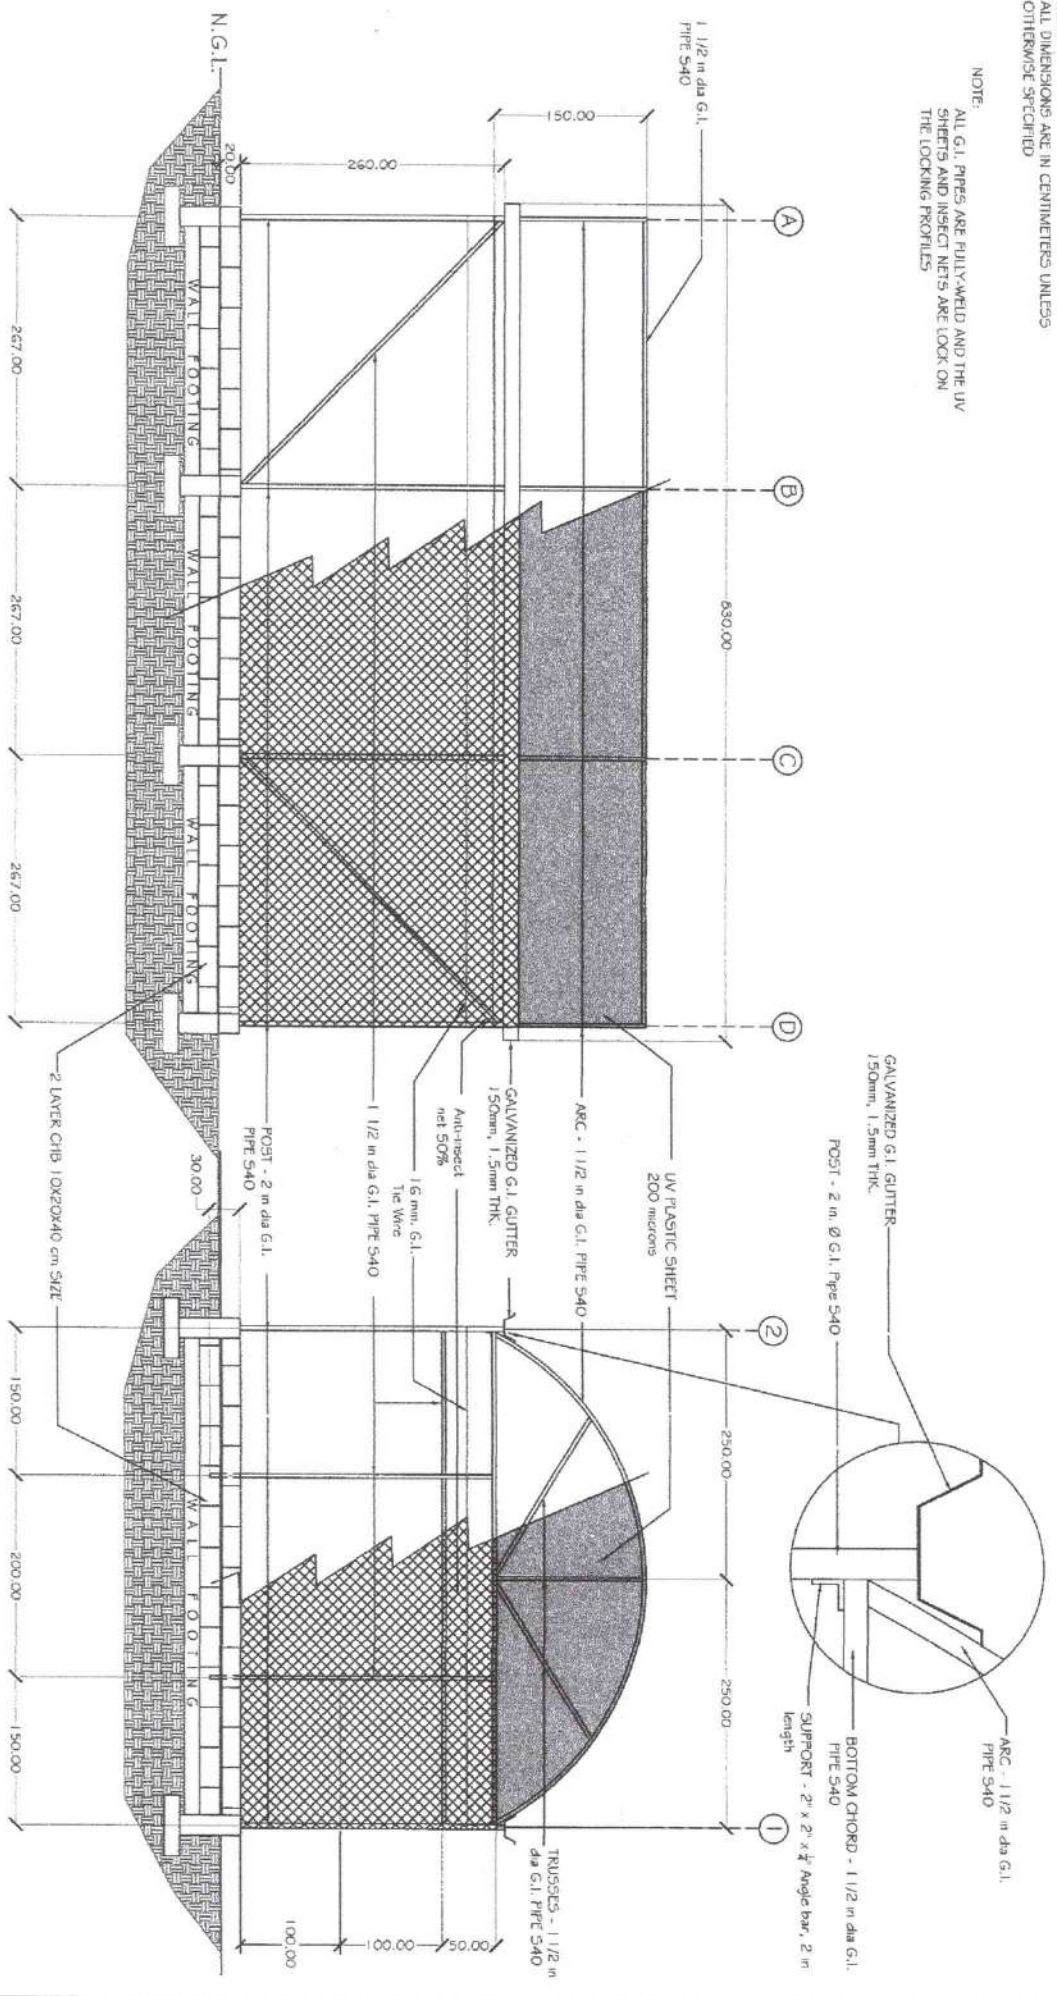

RIGHT ELEVATION


SCALE 1:50 MTS

REAR ELEVATION


SCALE 1:50 MTS

<p>Republic of the Philippines DEPARTMENT OF AGRICULTURE CARAGA REGION Capital Drive, Butuan City</p>	Project Title:	Prepared by:	Checked and Reviewed by:	Submitted by:	Noted by:	Recommended by:	Approved:	Sheet No.
	CONSTRUCTION OF MISCELLANEOUS STRUCTURES	DAN LOWELL S. PALMELAR HYCOP TECHNICAL STAFF	ENGR. JESSICA IVN D. LIMAS ENGINEER III	ENGR. ANNE Q. MARALES CHIEF RMD	DAIJUDA M. MAMALIS HYCOP FOCAL PERSON	REBECCA R. ATEGA RTO FOR OPERATIONS	ENGR. JERONDO M. ONATE, JR. REGIONAL EXECUTIVE DIRECTOR	2 3




NOTE:
ALL DIMENSIONS ARE IN CENTIMETERS UNLESS OTHERWISE SPECIFIED

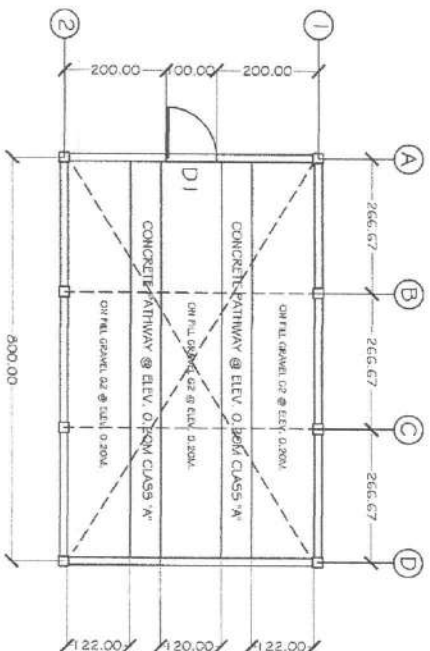


FLOOR PLAN
SCALE 1:100 MTS

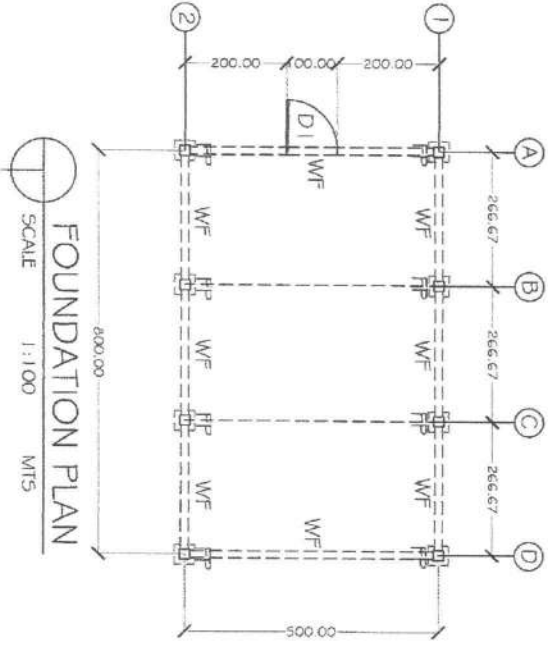

FOUNDATION PLAN
SCALE 1:100 MTS

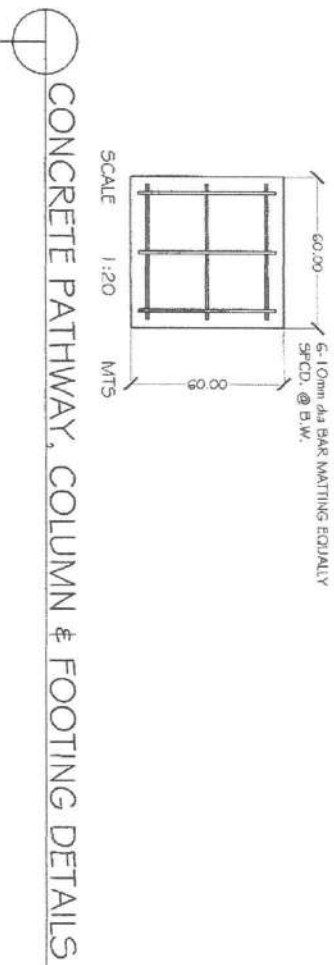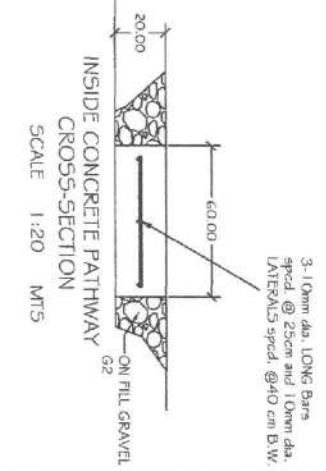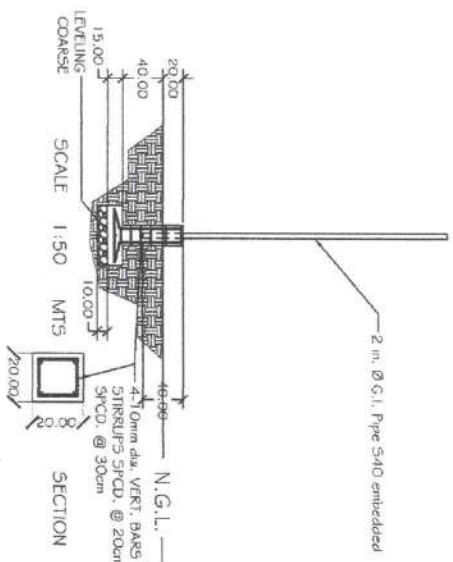

CONCRETE PATHWAY, COLUMN & FOOTING DETAILS
SCALE 1:20 MTS

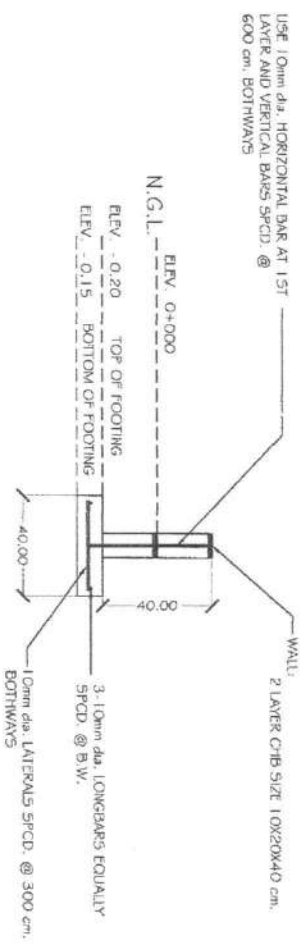


WALL FOOTING DETAILS
SCALE 1:20 MTS



<p>Republic of the Philippines DEPARTMENT OF AGRICULTURE CARAGA REGION Capital Drive, Butuan City</p>		<p>Project Title: CONSTRUCTION OF MAJOR VERTICAL SECTIONS</p>	<p>Prepared by: DAN DANIEL S. PALMELAR HYCOP TECHNICAL STAFF</p>	<p>Checked and Reviewed by: ENGR. THEO BALVIN B. UMAS ENGINEER III</p>	<p>Submitted by: ENGR. JIMMY M. MORALES CHIEF AND</p>	<p>Noted by: DOMINICAR MAMAUIS HYCOP FOCAL PERSON</p>	<p>Recommended by: REBECCA R. ALIGA RTD FOR OPERATIONS</p>	<p>Approved: ENGR. RICHARDO M. ONATE, JR. REGIONAL EXECUTIVE DIRECTOR</p>	<p>Sheet No. 3 9</p>
---	--	---	--	--	---	---	--	---	------------------------------

NOTE:
ALL DIMENSIONS ARE IN CENTIMETERS UNLESS OTHERWISE SPECIFIED

NOTE:
ALL G.I. PIPES ARE FULLY-WELDED AND THE UV SHEETS AND INSECT NETS ARE LOCK ON THE LOCKING PROFILES

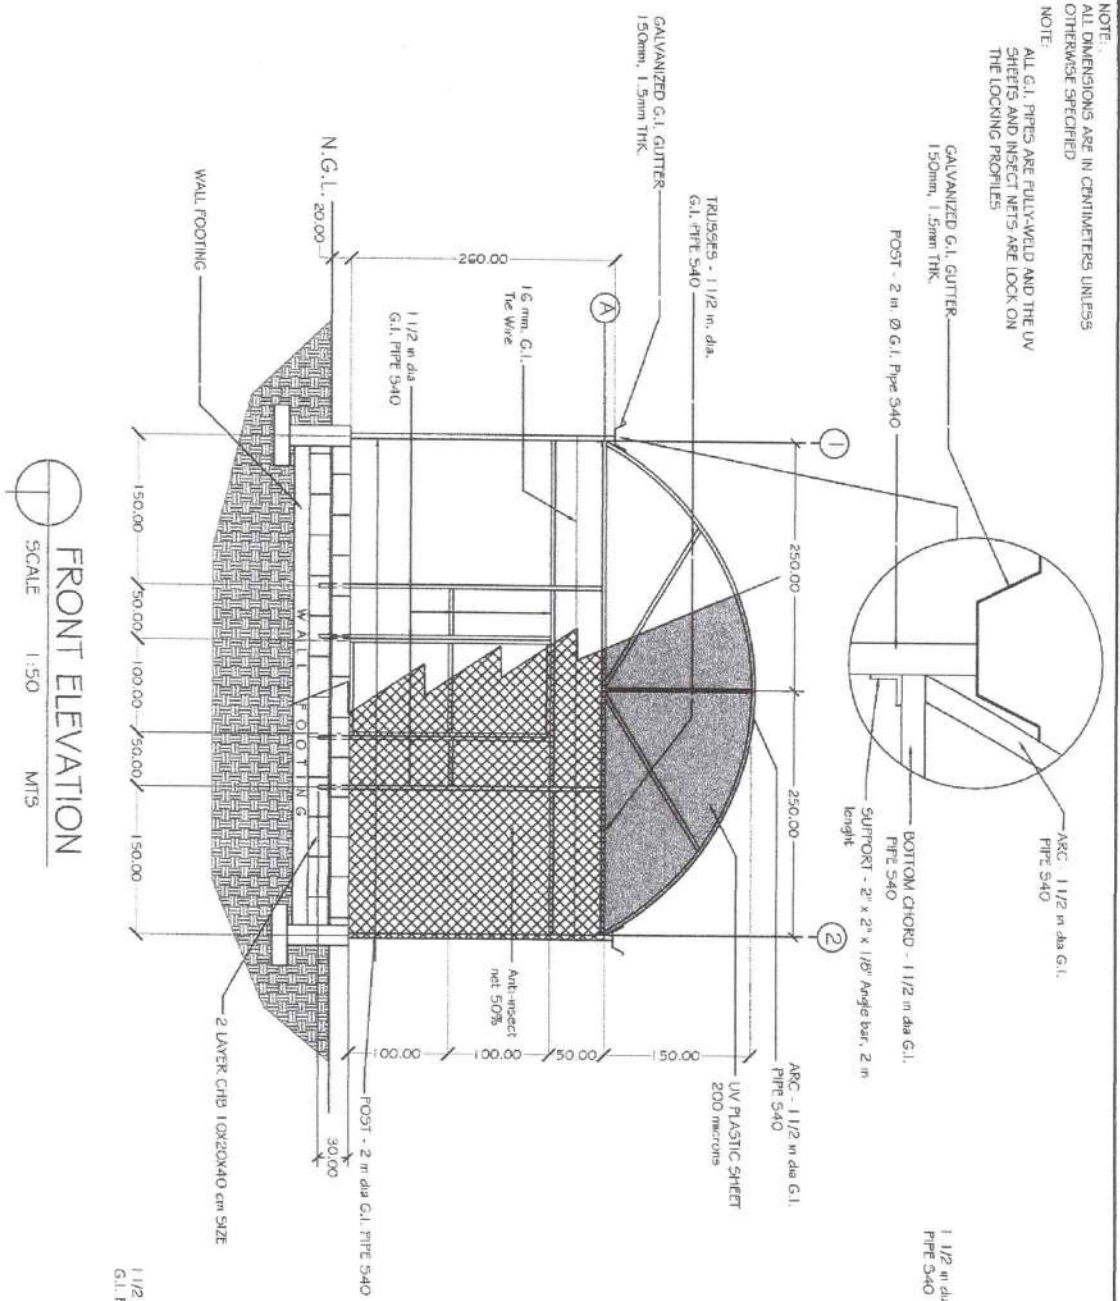


FRONT ELEVATION
SCALE 1:50
MTS

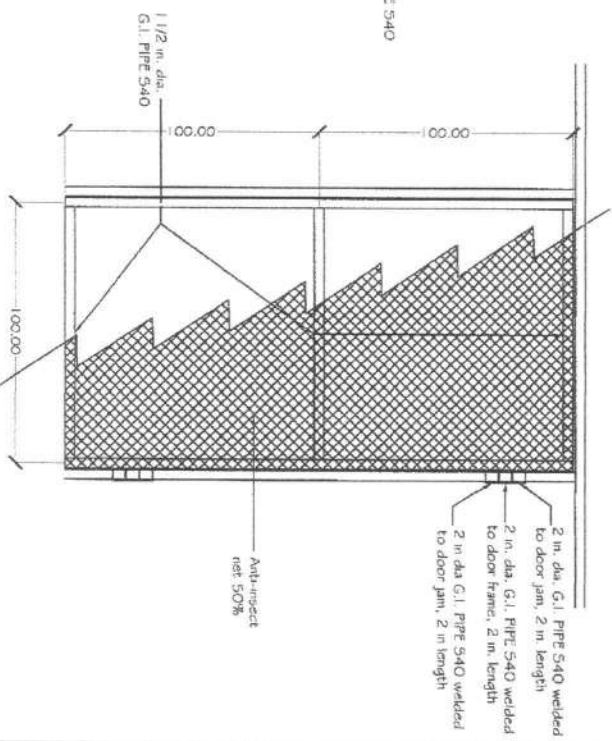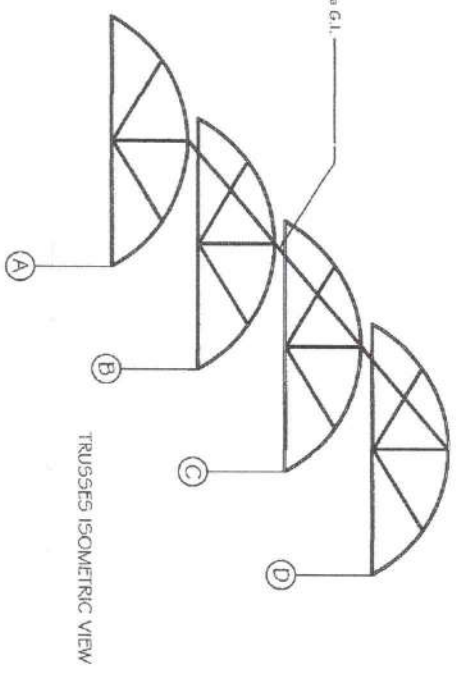


DOOR DETAILS (D1)
SCALE 1:20
MTS

 Republic of the Philippines DEPARTMENT OF AGRICULTURE CARAGA REGION Capital Drive, Butuan City	Project Title:	Prepared by:	Checked and Reviewed by:	Submitted by:	Noted by:	Recommended by:	Approved:	Sheet No.
	CONSTRUCTION OF MISERY FOR VEGETABLE SEEDBANK	 DAN IDANIEL S. PALMAR IN-CHARGE TECHNICAL STAFF	 ENGR. THEOBALD B. LIMAS ENGINEER III	 ENGR. DANILLO M. JIMENEZ CHIEF SAID	 DANILLO M. JIMENEZ IN-CHARGE FOCAL PERSON	 FERNANDO M. GARCIA RTO FOR OFFICE IN-CHARGE	 ENGR. DANILLO M. JIMENEZ, JR. REGIONAL EXECUTIVE DIRECTOR	

NOTE:
ALL DIMENSIONS ARE IN CENTIMETERS UNLESS OTHERWISE SPECIFIED

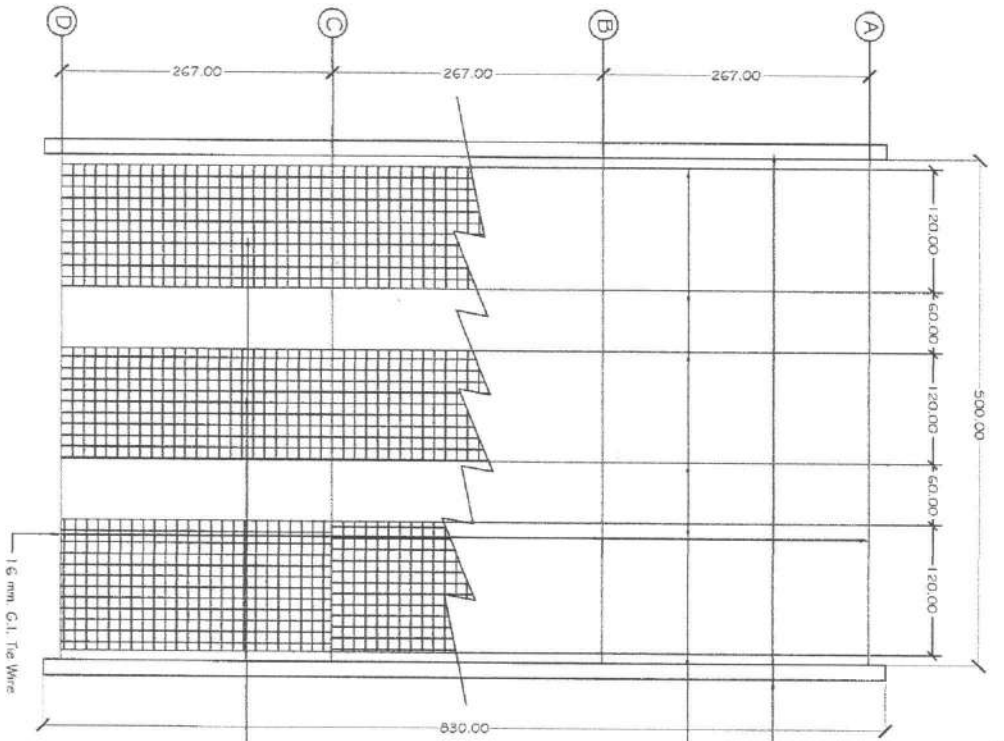

NOTE:
ALL G.I. PIPES ARE FULLY-WELDED AND THE UV SHEETS AND INSPECT NETS ARE LOCK ON THE LOCKING PROFILES

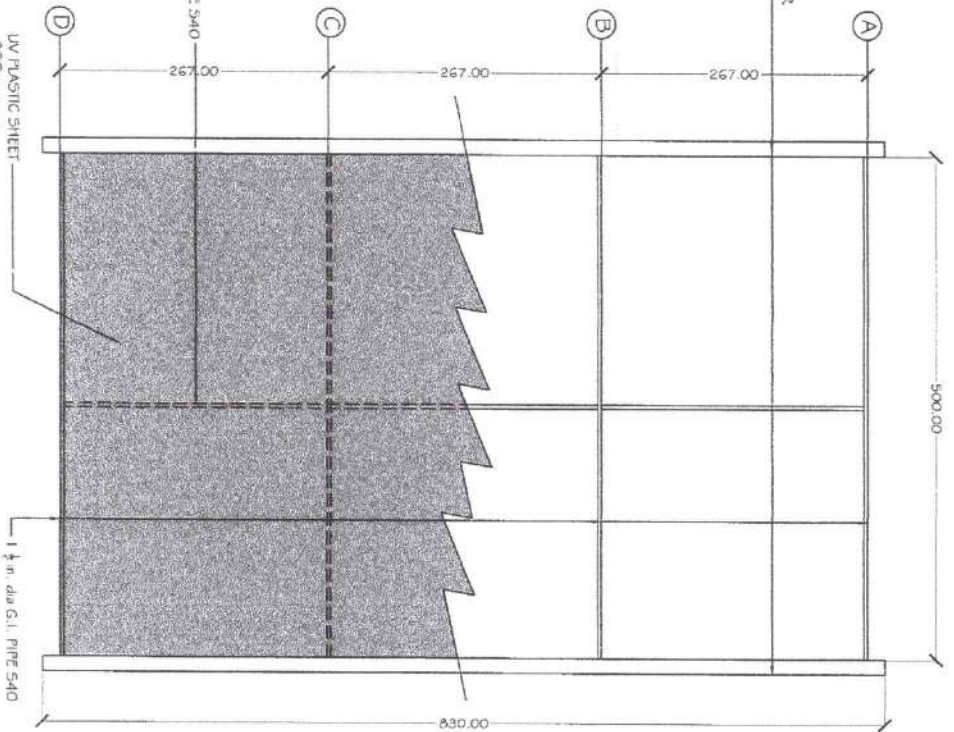

TOP ELEVATION (NET COVERING)
SCALE 1:50
MTS

TOP ELEVATION (TOP COVERING)
SCALE 1:50
MTS



Republic of the Philippines
DEPARTMENT OF AGRICULTURE
CARAGA REGION
Capitol Drive, Davao City

Project Title: CONSTRUCTION OF HUBSHEED FOR VEGETABLE SEEDINGS	Prepared by: <i>[Signature]</i> DAN I. DIMALI, S. PALMULAR INTEGR. TECHNICAL STAFF	Checked and Renewed by: <i>[Signature]</i> ENGR. THESSA LYN B. UMAS ENGINEER III	Submitted by: <i>[Signature]</i> ENGR. RICHARD CHIEF/END	Noted by: <i>[Signature]</i> DARLINDA D. MAMAMUS INTEGR. FOCAL PERSON	Recommended by: <i>[Signature]</i> REYNALDO M. ORATE R/D FOR OPERATIONS	Approved: <i>[Signature]</i> ENGR. REYNALDO M. ORATE, JR. REGIONAL EXECUTIVE DIRECTOR	Sheet No. 5 9
---	---	---	---	--	--	--	---------------------

NOTE:
ALL DIMENSIONS ARE IN CENTIMETERS UNLESS OTHERWISE SPECIFIED

NOTE:
ALL TUBULAR AND FLATBAR ARE FULLY WELD.





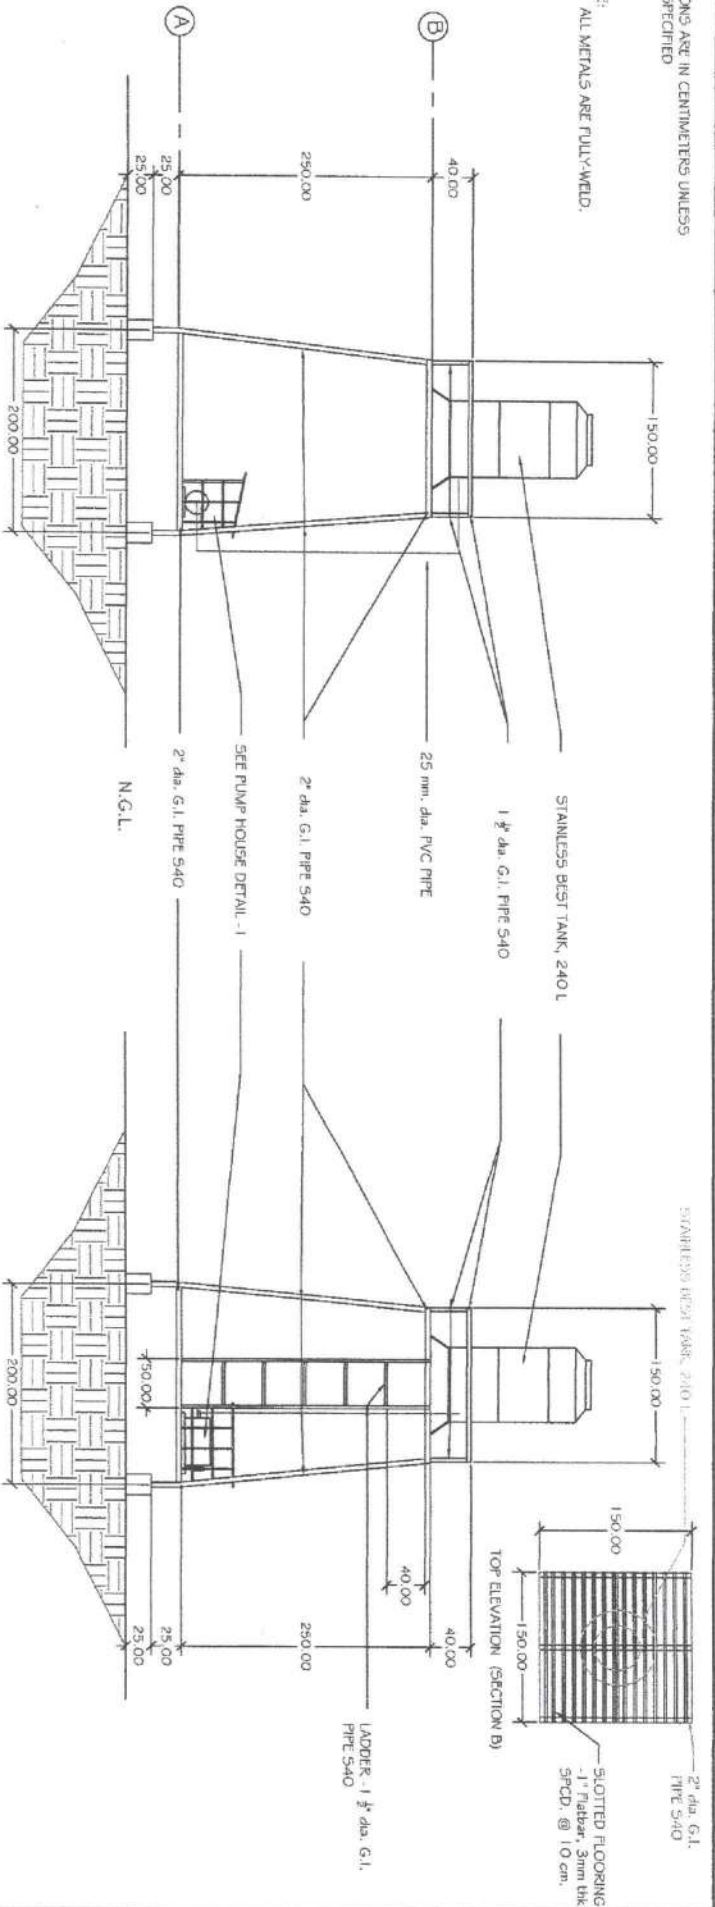


TABLE FOR SEEDLING TRAY (3 UNITS) DETAILS

 <p>Republic of the Philippines DEPARTMENT OF AGRICULTURE CARAGA REGION Capitol Drive, Butuan City</p>		<p>Project Title: CONSTRUCTION OF MUSEUM FOR VEGETABLE SEEDLINGS</p>	<p>Prepared by: <i>Dan Lowell S. Palmejar</i> DAN LOWELL S. PALMEJAR HYCDP TECHNICAL STAFF</p>	<p>Checked and Reviewed by: <i>Engr. Thelasa Lyn B. Limas</i> ENGR. THELASA LYN B. LIMAS ENGINEER III</p>	<p>Submitted by: <i>Engr. Jean O. Macavite</i> ENGR. JEAN O. MACAVITE CHIEF/REP</p>	<p>Noted by: <i>Dalinda M. Lamas</i> DALINDA M. LAMAS HYCDP FOCAL PERSON</p>	<p>Recommended by: <i>Rebeca S. Manansala</i> REBECA S. MANANSALA RFD FOR OPERATIONS</p>	<p>Approved: <i>Engr. Danilo M. Onate, Jr.</i> ENGR. DANILLO M. ONATE, JR. REGIONAL EXECUTIVE DIRECTOR</p>	<p>Sheet No. 6 9</p>
---	--	--	--	---	---	--	--	--	------------------------------


NOTE:
ALL DIMENSIONS ARE IN CENTIMETERS UNLESS OTHERWISE SPECIFIED

NOTE:
ALL METALS ARE FULLY WELD.

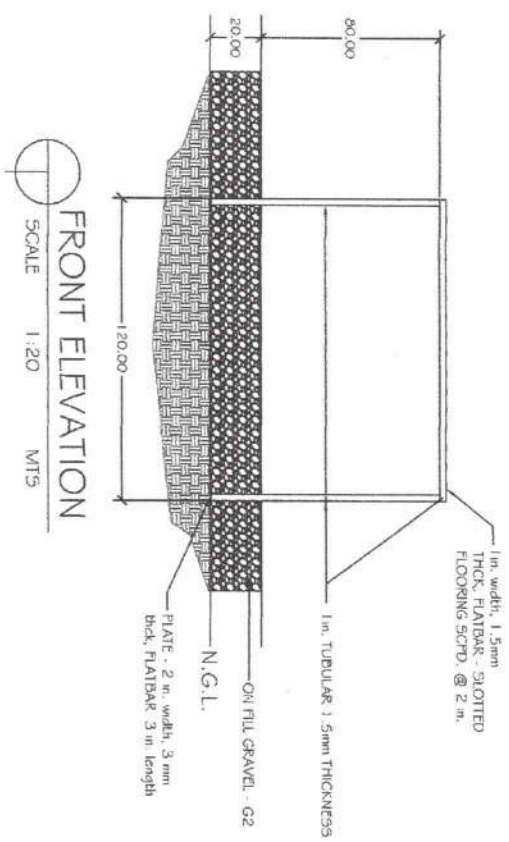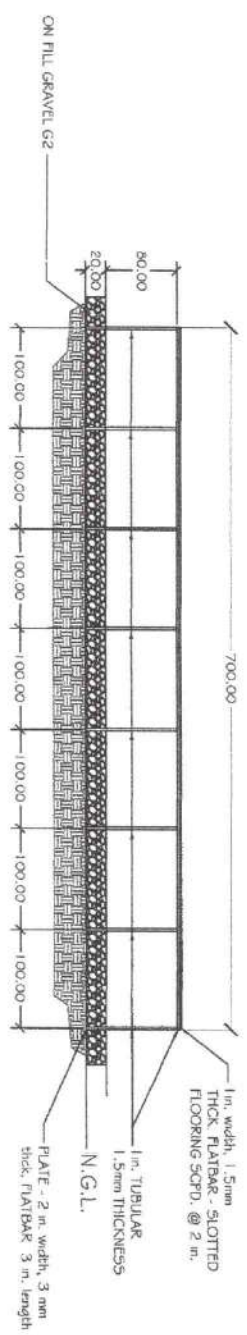
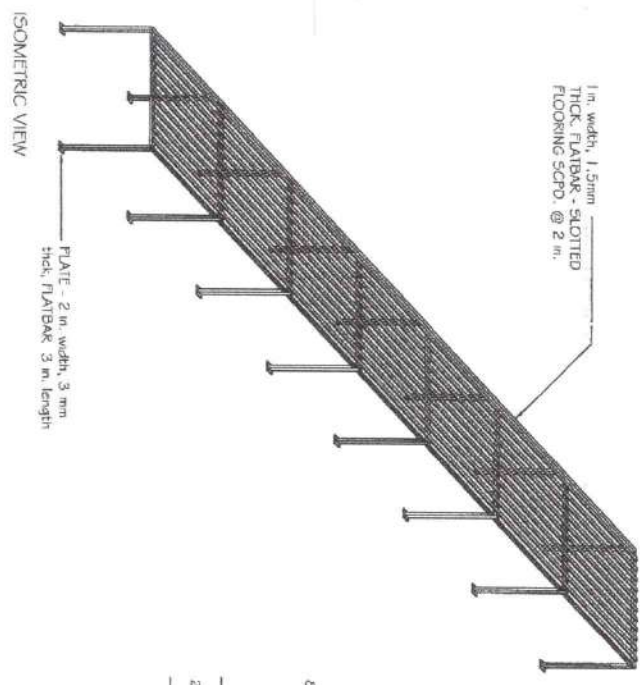


FRONT ELEVATION (ELEVATED WATER TANK)
SCALE 1:50 MTS

SIDE ELEVATION (ELEVATED WATER TANK)
SCALE 1:50 MTS

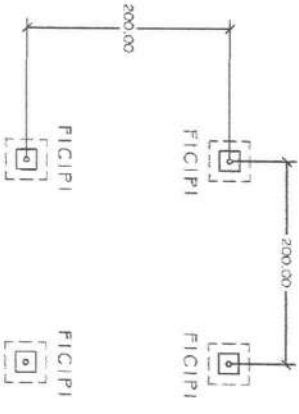

FOUNDATION PLAN
SCALE 1:50 MTS

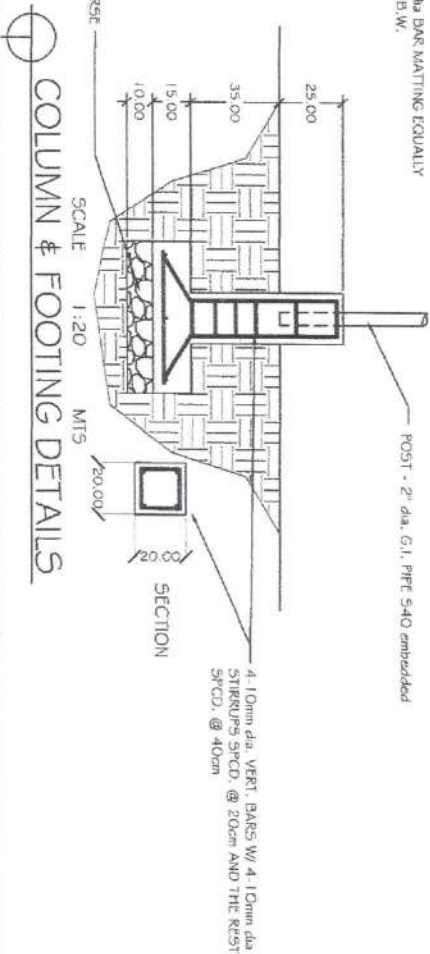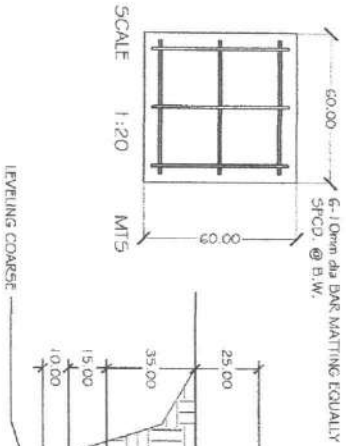

COLUMN & FOOTING DETAILS
SCALE 1:20 MTS




Republic of the Philippines
DEPARTMENT OF AGRICULTURE
CARAGA REGION
Capitol Drive, Butuan City


Project Title: CONSTRUCTION OF HANGER FOR VEGETABLE SEEDLINGS	Prepared by: <i>Alvin</i>	Checked and Reviewed by: ENGR. MICAELA D. LIMAS ENGINEER III	Submitted by: ENGR. DANIEL D. MARIAS CHIEF/RAID	Noted by: DARLINDA M. MANANALIS P/VCDF FOCAL PERSON	Recommended by: REBECCA R. RIVERA RID FOR OPERATIONS	Approved: ENGR. RICHARD M. ONATE, JR. REGIONAL EXECUTIVE DIRECTOR	Sheet No. 7 9
--	------------------------------	--	---	---	--	---	---------------------

NOTE:
ALL DIMENSIONS ARE IN CENTIMETERS UNLESS
OTHERWISE SPECIFIED

NOTE:
ALL METALS ARE FULLY WELD.

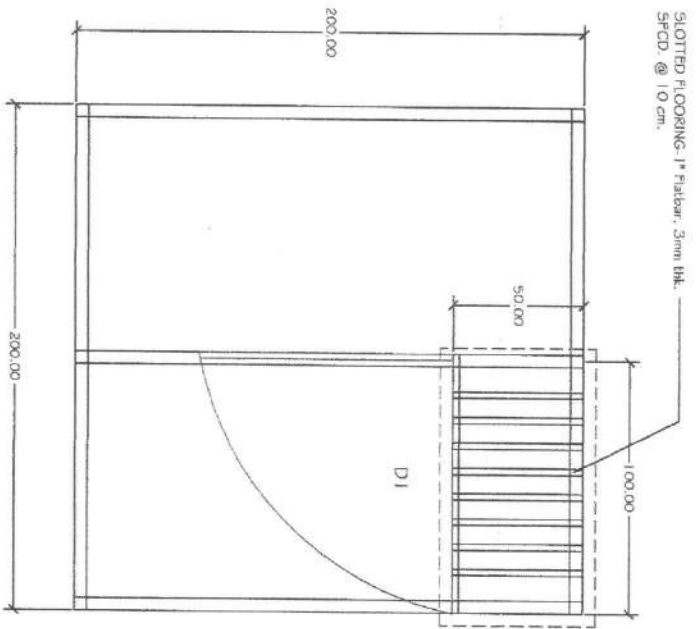


SECTION A
PUMP HOUSE DETAIL - I (POSITION)
SCALE 1:20
MTS

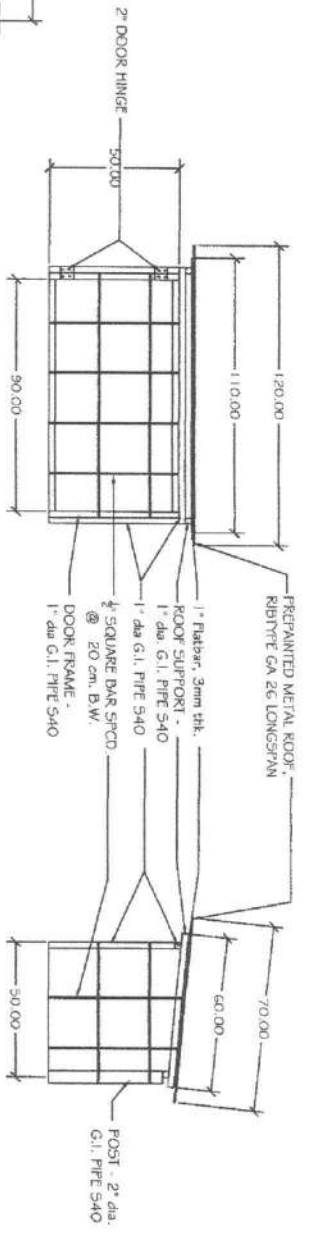


FRONT ELEVATION
SCALE 1:20
MTS

RIGHT ELEVATION
SCALE 1:20
MTS

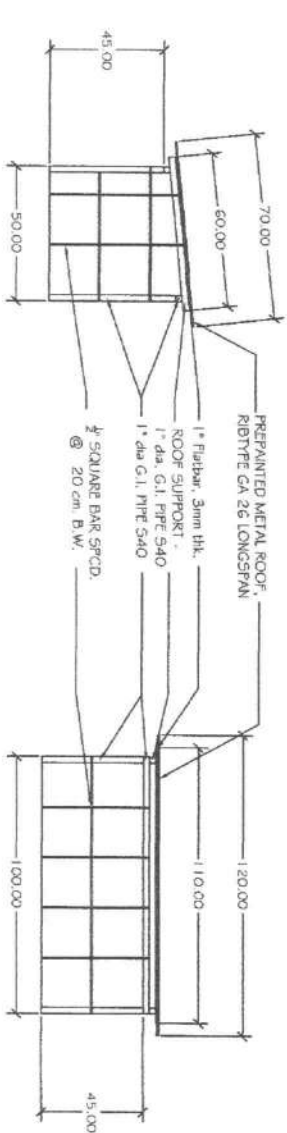





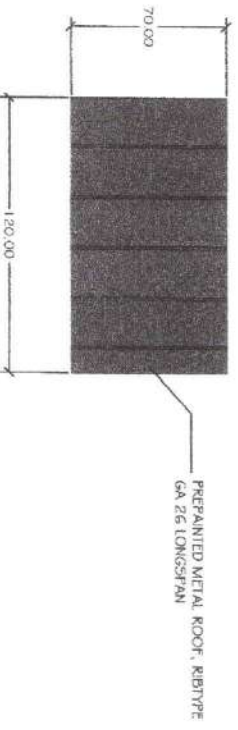



FRONT ELEVATION
SCALE 1:20
MTS


REAR ELEVATION
SCALE 1:20
MTS



TOP ELEVATION
SCALE 1:20
MTS

 DEPARTMENT OF AGRICULTURE CARAGA REGION Capitol Dvce, Butuan City	Republic of the Philippines DEPARTMENT OF AGRICULTURE CARAGA REGION Capitol Dvce, Butuan City	Project Title: CONSTRUCTION OF HURDLES FOR VEGETABLE SEEDLINGS	Prepared by:  DAN LOWELL S. PALMAR HVCIP TECHNICAL STAFF	Checked and Reviewed by:  ENGR. THERESA LYN B. LIMAS ENGINEER III	Submitted by:  ENGR. RENE O. MORALES CHIEF/AGENT	Noted by:  DALINDA V. MAMALIS H/ADP FOCAL PERSON	Recommended by:  REBECCA R. ATCH RTD FOR OPERATIONS	Approved:  ENGR. RICARDO M. ONATE, JR. REGIONAL EXECUTIVE DIRECTOR	Sheet No. 
--	--	---	--	--	--	--	---	--	--

NOTE:
ALL DIMENSIONS ARE IN CENTIMETERS UNLESS OTHERWISE SPECIFIED

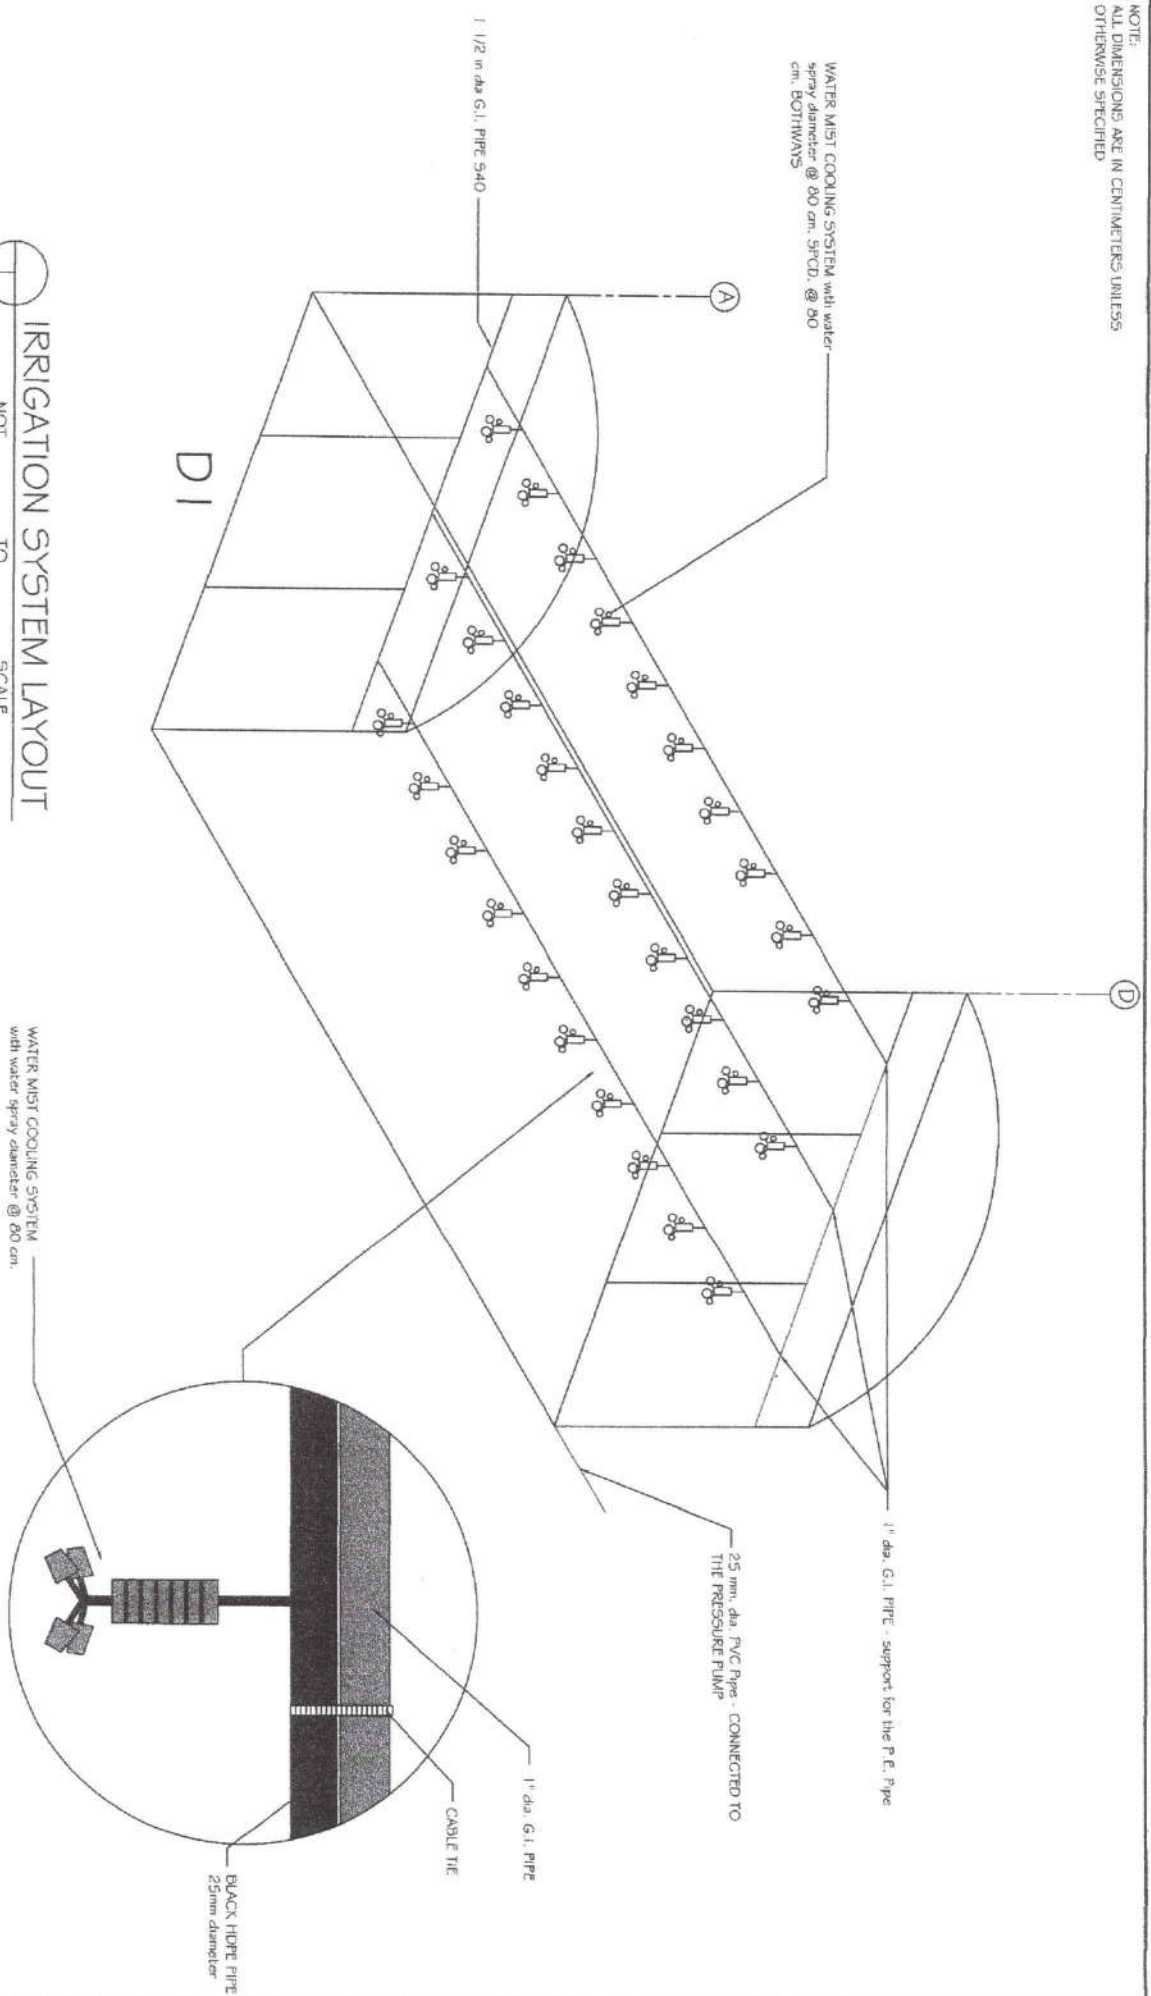

IRRIGATION SYSTEM LAYOUT
NOT TO SCALE

WATER MIST COOLING SYSTEM with water spray diameter @ 80 cm. SPCD. @ 90 cm. BOTHWAYS

25 mm. dia. PVC Pipe - CONNECTED TO THE PRESSURE PUMP


 
 
 

 

 
1" dia. G.I. PIPE - support for the P. E. Pipe

1" dia. G.I. PIPE

CABLE TIE

BLACK HOSE PIPE 25mm diameter

WATER MIST COOLING SYSTEM with water spray diameter @ 80 cm.

 Republic of the Philippines DEPARTMENT OF AGRICULTURE CARAGA REGION Capital Drive, Butuan City		Project Title: CONSTRUCTION OF HUDSONY FOR VEGETABLE SPREADERS	Prepared by:  DAN LOMEL S. PALMEJAR HVCDP TECHNICAL STAFF	Checked and Reviewed by:  ENGR. THESSA LYN B. LIMAS ENGINEER III	Submitted by:  ENGR. RAUL S. REYES CHIEF SAID	Noted by:  DALINDA M. MAVALIS HVCDP FISCAL PERSON	Recommended by:  REBECCA R. MAMBAS RTD FOR OPERATIONS	Approved:  ENGR. RAUL M. ONATE, JR. REGIONAL EXECUTIVE DIRECTOR	Sheet No. 
--	--	---	---	---	---	---	---	---	--