



REQUEST FOR QUOTATION

Date: _____
Quotation #: _____

Name of Company _____

Address _____

TIN _____

Please quote your lowest price inclusive of taxes in the items/s listed, subject to the General Conditions below, stating the shortest time of delivery. Submit your quotation duly signed by your representative not later than 3 days upon receipt in sealed envelope marked with the reference no. (PR # 24-03-SP139).

[Signature]
JOHNNY M. CONCON
Chairman, Bids and Awards Committee

ITEM NO.	ITEM & DESCRIPTION	UNIT	QUANTITY	UNIT COST	TOTAL COST
	Procurement of Labor and Materials for the Construction of Automated Weather Station (AWS) Perimeter Fence	unit	2		
	Location:				
	1. Jabonga, Agusan del Norte				
	2. San Francisco, Surigao del Norte				
	(See attached POW and DED)				
	Note: In reference to the Practice of Professional Agricultural Engineers, pursuant to RA 10915, all plans, designs, drawings, estimates, specifications, and other documents related to agriculture both public and private, shall be signed, stamped and sealed by Agricultural and Biosystems Engineers				

ABC: 140,000.00
Source of fund: MCRA CY 2024 Funds

General Conditions:

- All entries must be typewritten/printed in ink.
- Delivery period within _____ calendar days based on the contract.
- Warranty shall be for a period of six (6) months for supplies & materials, one (1) year for equipment from date of acceptance by procuring entity.
- Price validity shall be for a period of _____ calendar days
- PhilGEPS Registration Certificate, Business Permit, DTI Certificate and Tax Registration Certificate shall be attached upon submission of the quotation, if applicable.
- Bidders shall submit original brochures showing specification of the products being offered.
- Winning bidder(s) from outside Butuan City must appear personally or sent authorized representative to signed contract and claimed payments.

After having carefully read and accepted your General Conditions, I/We quote on the item at prices noted above.

Printed Name/Signature of Company

Name and Signature of Convasser

Tel. No. / CP No. / email address


DEPARTMENT OF AGRICULTURE - CARAGA
Capitol Site, Butuan City



**CONSTRUCTION OF AUTOMATED WEATHER
STATION (AWS) PERIMETER FENCE**


Item No.	Description	Quantity	Unit
B.5	Project Billboard/Signboard	1	each
803 (1) a	Structure Excavation	0.56	cu.m
900	Reinforced Concrete	0.56	cu.m
901	Mansory Works	4.8	sq.m
1027 (a)	Cement Plaster Finish	4.8	sq.m
403 (7)	Structural Steel Furnished Fabricated and Erected	200	kg
Spl-1	Installation of Cyclone Wire & Barbed Wire	10	LNM

 Republic of the Philippines DEPARTMENT OF AGRICULTURE RFO VIII, Capitol Site, Bulacan City	Project Title: CONSTRUCTION OF AUTOMATED WEATHER STATION (AWS) PERIMETER FENCE Location: Various Location		Prepared by:  MARK LOUIE C. BACALSO COS - AIA Project	Checked & Reviewed by:  THEODORA S. ZAYAS Engineer	Submitted by:  EDELFIIRA R. LUMANARAN Chief, Research Division	Noted:  EDELFIIRA R. LUMANARAN Chief, Research Division	Recommending approval:  ASST. F. WAGAS RTD for Research & Regulations	Approved:  RODOLFO M. ORATE, JR. Regional Executive Director	Sheet no.  1
--	--	--	---	--	--	---	---	--	---

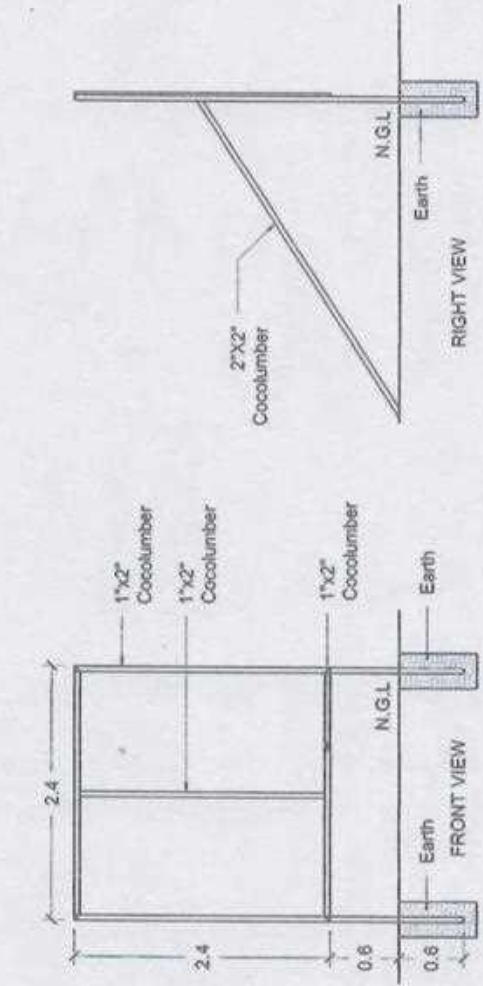


1
A-2


SCALE 1:50
 MTS

 <p style="text-align: center;"> Republic of the Philippines DEPARTMENT OF AGRICULTURE Caraga Region Capital Site, Butuan City Tel. No. (085) 342-6092, Telex No. (085) 342114 Fax No. (085) 342-6093 </p>		<p> Project Name: Construction of Automated Weather Station (AWS) Perimeter Fence Location: Various location Implementing Agency: DA-Caraga Region Development Partners: Contractor: Supplier Brand Description: </p>		<p> Costs Fund Source/s: </p>	
Project Details					
Project Date		Project Status		Remarks	
Duration:	Started:	Target Date of Completion:	Percentage of Completion:	As of (Date):	Date Completed:
15 C.O.					
<p> For particulars or complaints about this project, please contact Regional Office or Cluster which has jurisdiction on this project. </p>					
<p> COA Regional Office No. Cluster: XIII-CARAGA Address: SOUTH MONTILLA BOULEVARD, BUTUAN CITY Contact No. (085) 342-567 or ext COA Cluster's Desk at (0915) 539155 </p>					


 <p style="text-align: center;"> Republic of the Philippines DEPARTMENT OF AGRICULTURE RFO XIII, Capital Site, Butuan City </p>	<p>Project Title:</p> <p>CONSTRUCTION OF AUTOMATED WEATHER STATION (AWS) PERIMETER FENCE</p> <p>Location: Various Location</p>	<p>Prepared by:</p> <p><i>Mark Louie C. Bacalso</i> MARK LOUIE C. BACALSO COS - AIA Project</p>	<p>Checked & Reviewed by:</p> <p><i>Theresa Lyn B. Tomas</i> THERESA LYN B. TOMAS Engineer II</p>	<p>Submitted by:</p> <p><i>Renzo Magales</i> RENZO MAGALES Zonal Based</p>	<p>Noted:</p> <p><i>Edelmir R. Lumbiaras</i> EDELMIR R. LUMBARIAS Chief, Research Division</p>	<p>Recommending approval:</p> <p><i>Abel F. Magas</i> ABEL F. MAGAS RTD for Research & Regulations</p>	<p>Approved:</p> <p><i>Engr. Ricardo M. Onate, Jr.</i> ENGR. RICARDO M. ONATE, JR. Regional Executive Director</p>	<p>Sheet no.</p> <table border="1" style="margin: auto;"> <tr> <td style="width: 20px; height: 20px; text-align: center;">1</td> </tr> <tr> <td style="width: 20px; height: 20px; text-align: center;">2</td> </tr> </table>	1	2
1										
2										

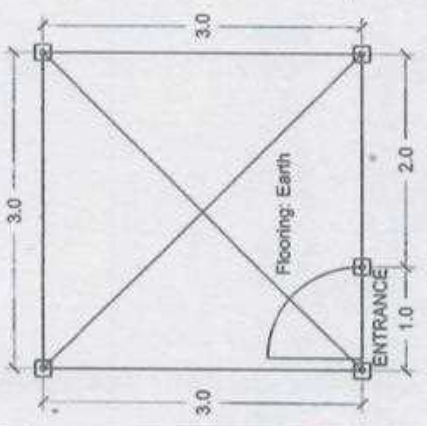


1
A-1
SCALE 1:50
FLOOR PLAN
MTS

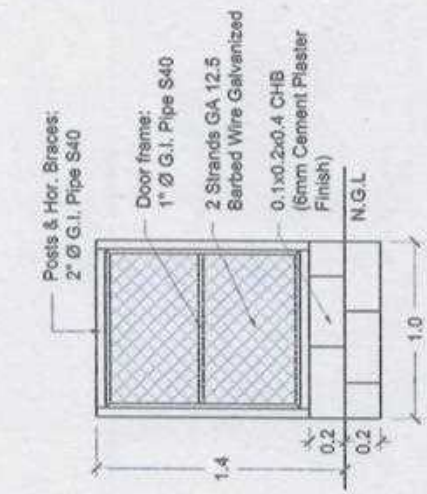


1
A-1
SCALE 1:30
DOOR DETAILS
MTS

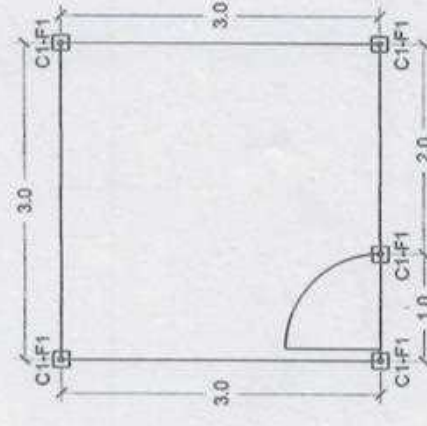


1
A-1
SCALE 1:50
FOUNDATION PLAN
MTS

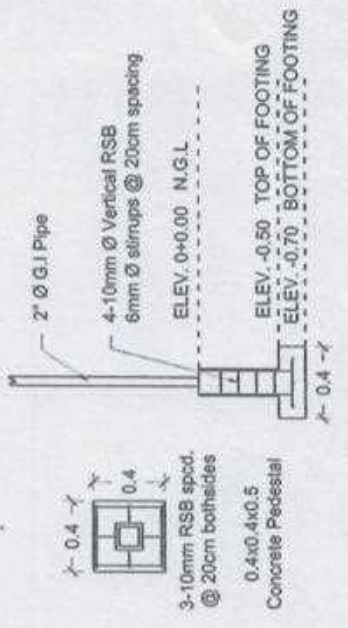


1
A-1
SCALE 1:30
C1-F1 DETAILS
MTS

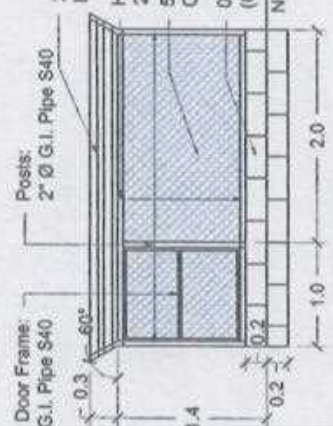

1
A-1
SCALE 1:50
FRONT ELEVATION
MTS

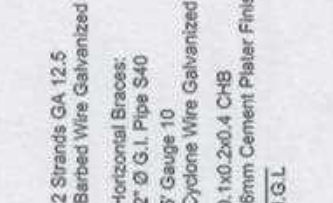

1
A-1
SCALE 1:50
BACK ELEVATION
MTS

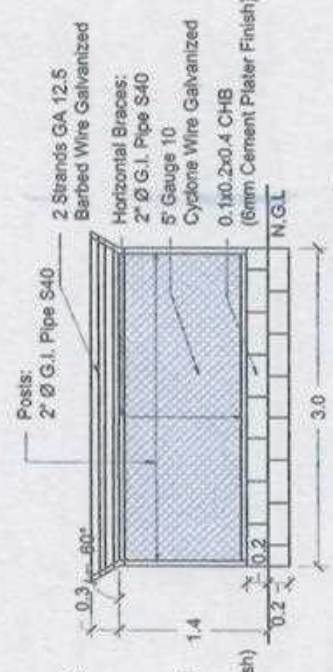

1
A-1
SCALE 1:50
RIGHT ELEVATION
MTS

<p>Republic of the Philippines DEPARTMENT OF AGRICULTURE PFO XIII, Capitol Site, Bulacan City</p>	<p>Project Title: CONSTRUCTION OF AUTOMATED WEATHER STATION (AWS) PERIMETER FENCE Location: Various Location</p>	<p>Prepared by: MARK LOUIE C. BACALSO COS - AIA Project</p>	<p>Checked & Reviewed by: THESSALYN B. LUMAS Supervisor</p>	<p>Submitted by: RESERVA R. LUMINARAS Civil Engr.</p>	<p>Noted: EDLWINA R. LUMINARAS Civil Engr. Division</p>	<p>Recommending approval: ALEX F. WALKAS RTD for Research & Regulations</p>	<p>Approved: ENGR. RODRIGO M. ONATE, JR. Regional Executive Director</p>	<p>Sheet no. 2 2</p>
	<p>9/7</p>							